


- 0.25 lux
- 0.5 lux
- 1.0 lux
- 3.0 lux
- 5.0 lux

Notes:
 All LED luminaires must have Constant Light Output (C.L.O.)
 Automatically dimmed to 75% each night from 12 midnight to 6am.
 (L14 Profile)
 All luminaires to have 7pin NEMA sockets fitted.
 Electronic Photocontrols switched at 35/18lux
 All columns, luminaires, cable and pillars, shall comply with Local Authority
 General Specification for Public Lighting.
 No trees to be located within falling distance of PL columns.
 Minimum set-back of columns is 800mm from face of kerb.
 Public lighting cable chamber as per Local Authority PL Dept. specification.

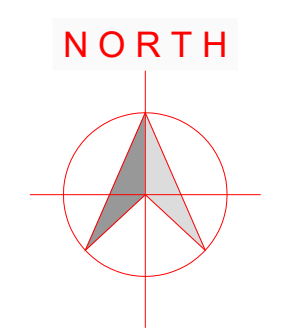


- Luminaire A AXIA 2.1 5165 Rear louvers 16@300mA WW 727 Qty 66 5m mounting height Raise & Lower column.
- Luminaire E E950-28-R3P-727-C300-01W Qty 57 5m mounting height Raise & Lower column.
- Luminaire G E950-28-P4A-727-C350-10W Qty 2 5m mounting height Raise & Lower column.
- Luminaire H E950-28-A2A-727-C650-17W Qty 5 5m mounting height Raise & Lower column.
- Luminaire I E951-64-P4-G-727-W5-0700-62W Qty 80 10m mounting height.
- Luminaire J E950-28-P4A-727-C550-14W Qty 138 6m mounting height.
- Luminaire L E950-28-P4A-727-C350-10W Qty 91 6m mounting height.
- Luminaire M E950-28-F2A-727-C700-18W Qty 11 6m mounting height.
- Luminaire N E950-28-P4A-727-SA0675-29W Qty 9 6m mounting height.

20kVg NYC cable laid in ducting to I.S.10101:2020. Single wall ducting, colour red to be used manufactured from high density polyethylene (H.D.P.E.), 107mm external diameter, having a wall thickness of 5mm. This ducting to have the words "Street Lighting" stamped on outer size every 1m intervals. The lettering to face uppermost in the trench. All works to Local Authority specification. This is a circuit layout and not indicative of where ducts are to be laid.
 Public Lighting Pillar (located at least 2m from ESB pillar)

Typical Base detail, to be checked by site engineers.

COLUMN MOUNTING HEIGHT	12m	10m	8m	6m
COLUMN ROOT DEPTH	1.9m	1.7m	1.5m	1.0m
CABLE ENTRY DEPTH	0.3m	0.3m	0.3m	0.3m
ROOTING CONCRETE DEPTH				
COLUMN DOOR HEIGHT	1.5m	1.5m	1.5m	1.5m
COLUMN SLEEVE SIZE(mm) internal	450	400	400	300
EXCAVATION (width x length)	1000	800	600	400

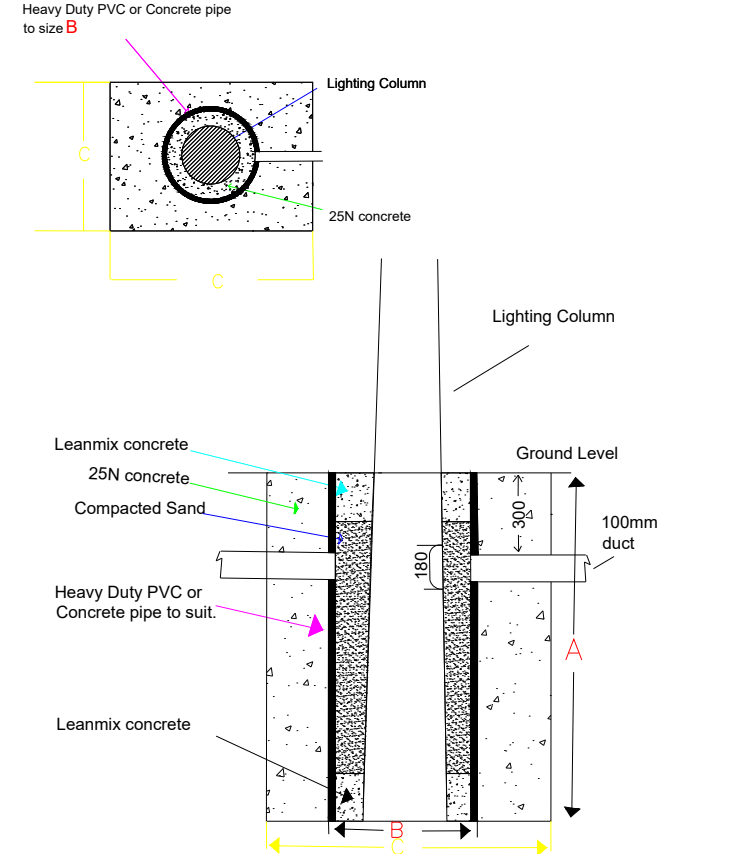

NOTES
 THIS DRAWING IS THE INTELLECTUAL PROPERTY OF Sabre LIGHTING DESIGN DEPT. AND IS COPYRIGHT © AND CAN NOT BE USED WITHOUT PRIOR CONSENT.

NO ACCOUNT IS TAKEN FOR THE BLOCKING EFFECT CAUSED BY BUILDINGS, TREES ETC. THE CALCULATION SHOWN BY THIS DRAWING ASSUMES THAT THE WHOLE AREA BEING CONSIDERED IS IN THE SAME PLANE, I.E. THERE ARE NO CHANGES IN GRADIENT OR ELEVATION.

This drawing layout is based on calculated lighting levels, produced by Sabre Electrical Services Ltd., using Lighting Really software. Any alterations to the layout or luminaire type used for the lighting design calculations, will require a revised lighting design to be carried out. A redesign may require approval from the Local Authority Public Lighting Dept. prior to any alterations/modifications being implemented on site.

Sabre

ELECTRICAL SERVICES LTD.
 Specialist Contractors
 PUBLIC LIGHTING - FLOOD LIGHTING - SPORTS LIGHTING

UNIT 11, BELLVUE INDUSTRIAL ESTATE, FINGLAS, DUBLIN 11.
 E-MAIL: graham@sabrelighting.ie PH: 01-811 0875

?	GS	CHK	-----
?	GS	CHK	-----
?	GS	CHK	-----
?	GS	CHK	-----
?	GS	CHK	-----
B	AN	CHK	03-05-22
A	AN	CHK	03-05-22
REV	DESCRIPTION	INTS	CHK'D DATE

CLIENT/CUSTOMER
Gerard Gannon Properties

PROJECT
SHD Development Belcamp

TITLE
Public Lighting Layout

DRAWN
 A.N SCALE 1:1000 @A1 DATE 27-04-22

DRAWING NUMBER
SES 05322-2 Sheet 2 ISSUE 3

BASE DRAWING NUMBER
 1520_WIP_Rev5_29-04-22.dwg
 DRAWING ORIGIN
 TBS
DO NOT SCALE FROM THIS DRAWING